



NOTES

1. LOD IS SHOWN FOR CONTINGENCY ONLY AND THE SCES SHOULD BE COORDINATED IN THE FIELD IN THE EVENT OF OVER EXCAVATION.

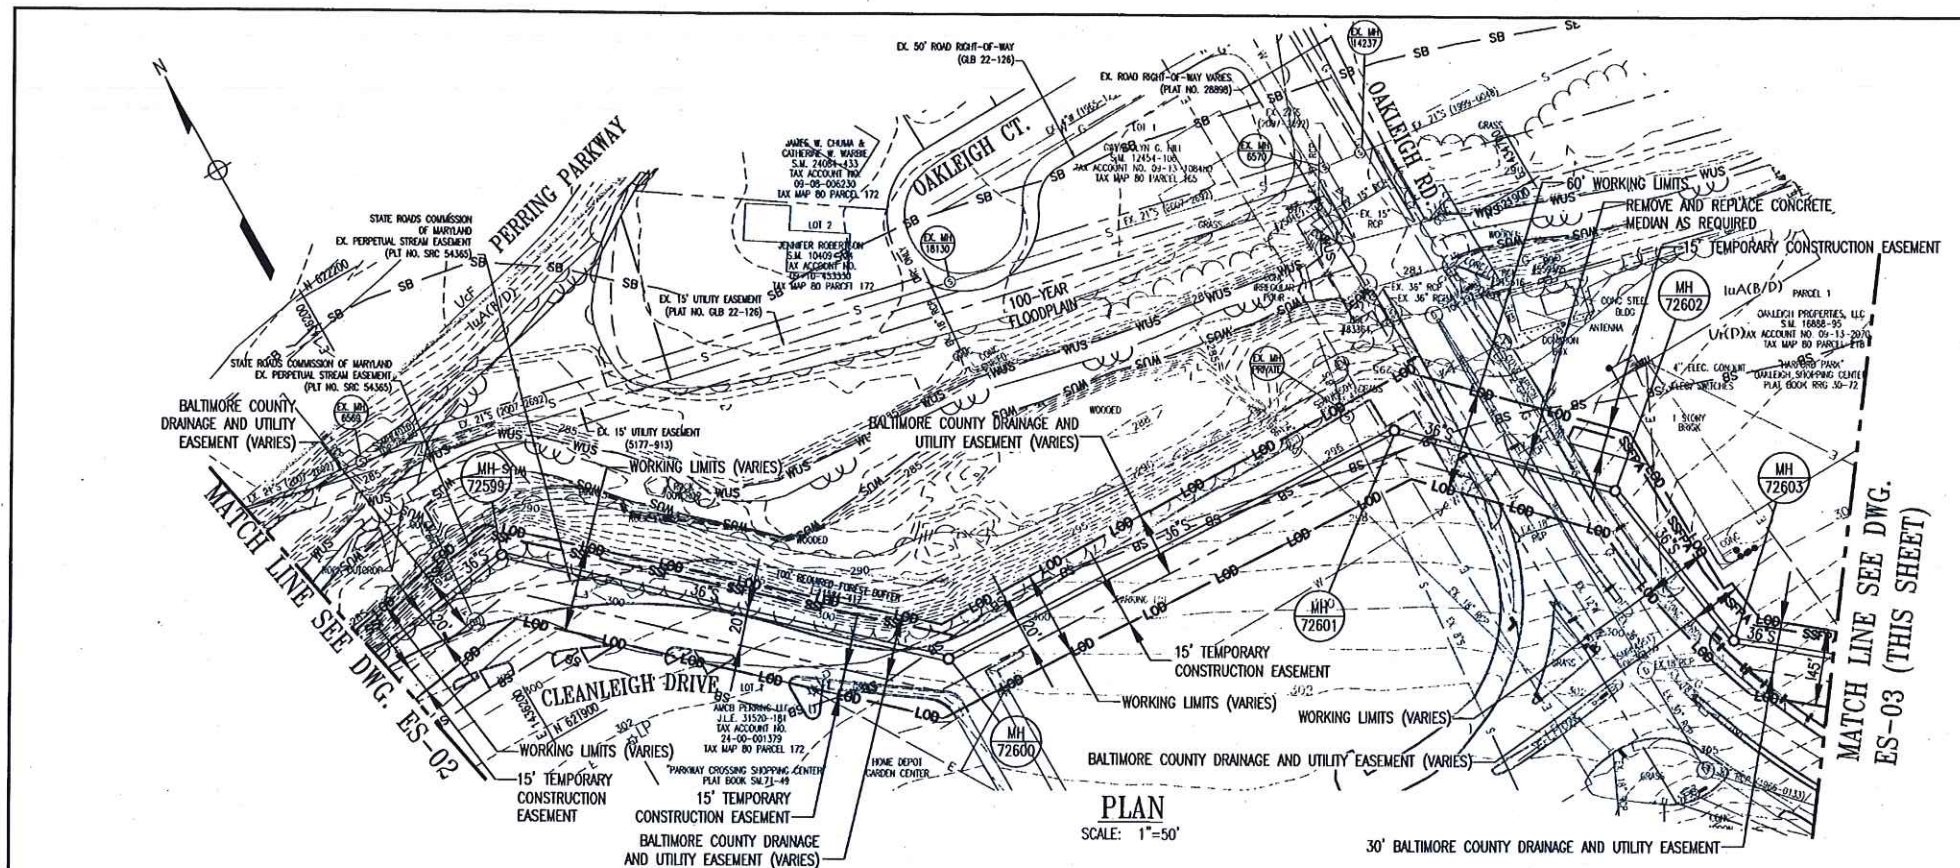

MATCH LINE SEE DWG. ES-03 (THIS SHEET)

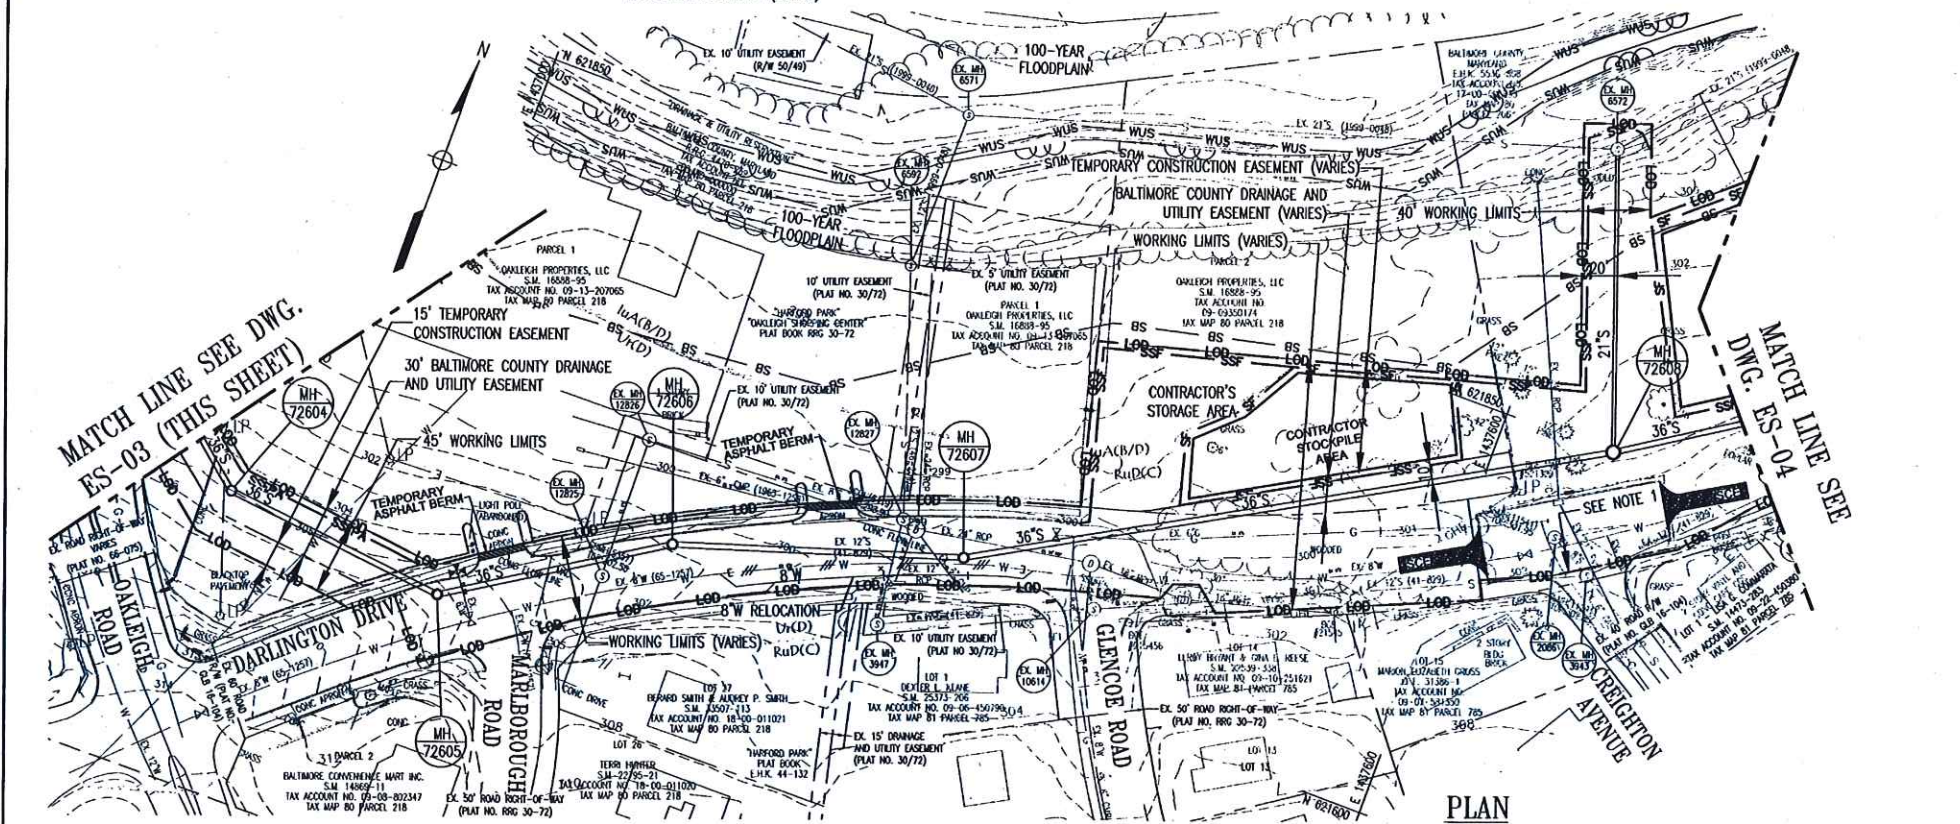

MATCH LINE SEE DWG. ES-03 (THIS SHEET)

MATCH LINE SEE DWG. ES-04 (THIS SHEET)

Baltimore County Soil Conservation District
APPROVED FOR SEDIMENT CONTROL
Jeffrey E. West
Date: 6-22-15

Design & Drawing based on Maryland Coordinate System
Horizontal - NAD83 (NSRS2007)
Vertical - NAVD83




EAST BRANCH
HERRING RUN
SSO #41 & #129
CONSENT DECREE

PROFESSIONAL CERTIFICATION		REVISION		BY	DATE	P.W.A. NO.	KEY SHEET	POSITION	SHT	DRAWING SCALE	DEPARTMENT OF PUBLIC WORKS
I HEREBY CERTIFY THAT THESE DOCUMENTS WERE PREPARED OR APPROVED BY ME, AND THAT I AM A DULY LICENSED PROFESSIONAL ENGINEER UNDER THE LAWS OF THE STATE OF MARYLAND. LICENSE NO. 32665, EXPIRATION DATE 06/26/2020											
ENGINEER: KEVIN WALKER PHOENIX ENGINEERING, INC 81332 OLD YORK ROAD PARKTON, MD 21120	DESIGN BY: RW	BUREAU OF ENGINEERING AND CONSTRUCTION	BUILDINGS	HIGHWAYS	STRUCTURES	STORM DRAINS	SEWER	WATER	FIELD ENGINEER	BUR. OF ENGINEERING & CONSTRUCTION	
AS-BUILT PER RECORD PRINT	DRAWN BY: SEP	REVIEWED BY:									
BY: DATE:	CHKD BY: KVM	DATE REVIEWED:									

BALTIMORE COUNTY DEPARTMENT OF PUBLIC WORKS BUREAU OF ENGINEERING & CONSTRUCTION
EAST BRANCH HERRING RUN RELIEF SEWER
GRADING AND SEDIMENT & EROSION CONTROL PLAN
SUBDIVISION: PARKVILLE BALTIMORE COUNTY ELECTION DIST. NO.: 9C5


SHEET DESIGNATION	CONTRACT NUMBER
ES-03	14117-SKO
	JOB ORDER NUMBER
	201-0077-7103
	SHEET 32 OF 76
	DRAWING NUMBER
	2014-1573
	FILE NO.:

DWG. FILENAME: G:\15113-000.01 BALTO CO PERRING PARK RELIEF SEWER (HERRING RUN EAST BRANCH)\E01PERRING.DWG

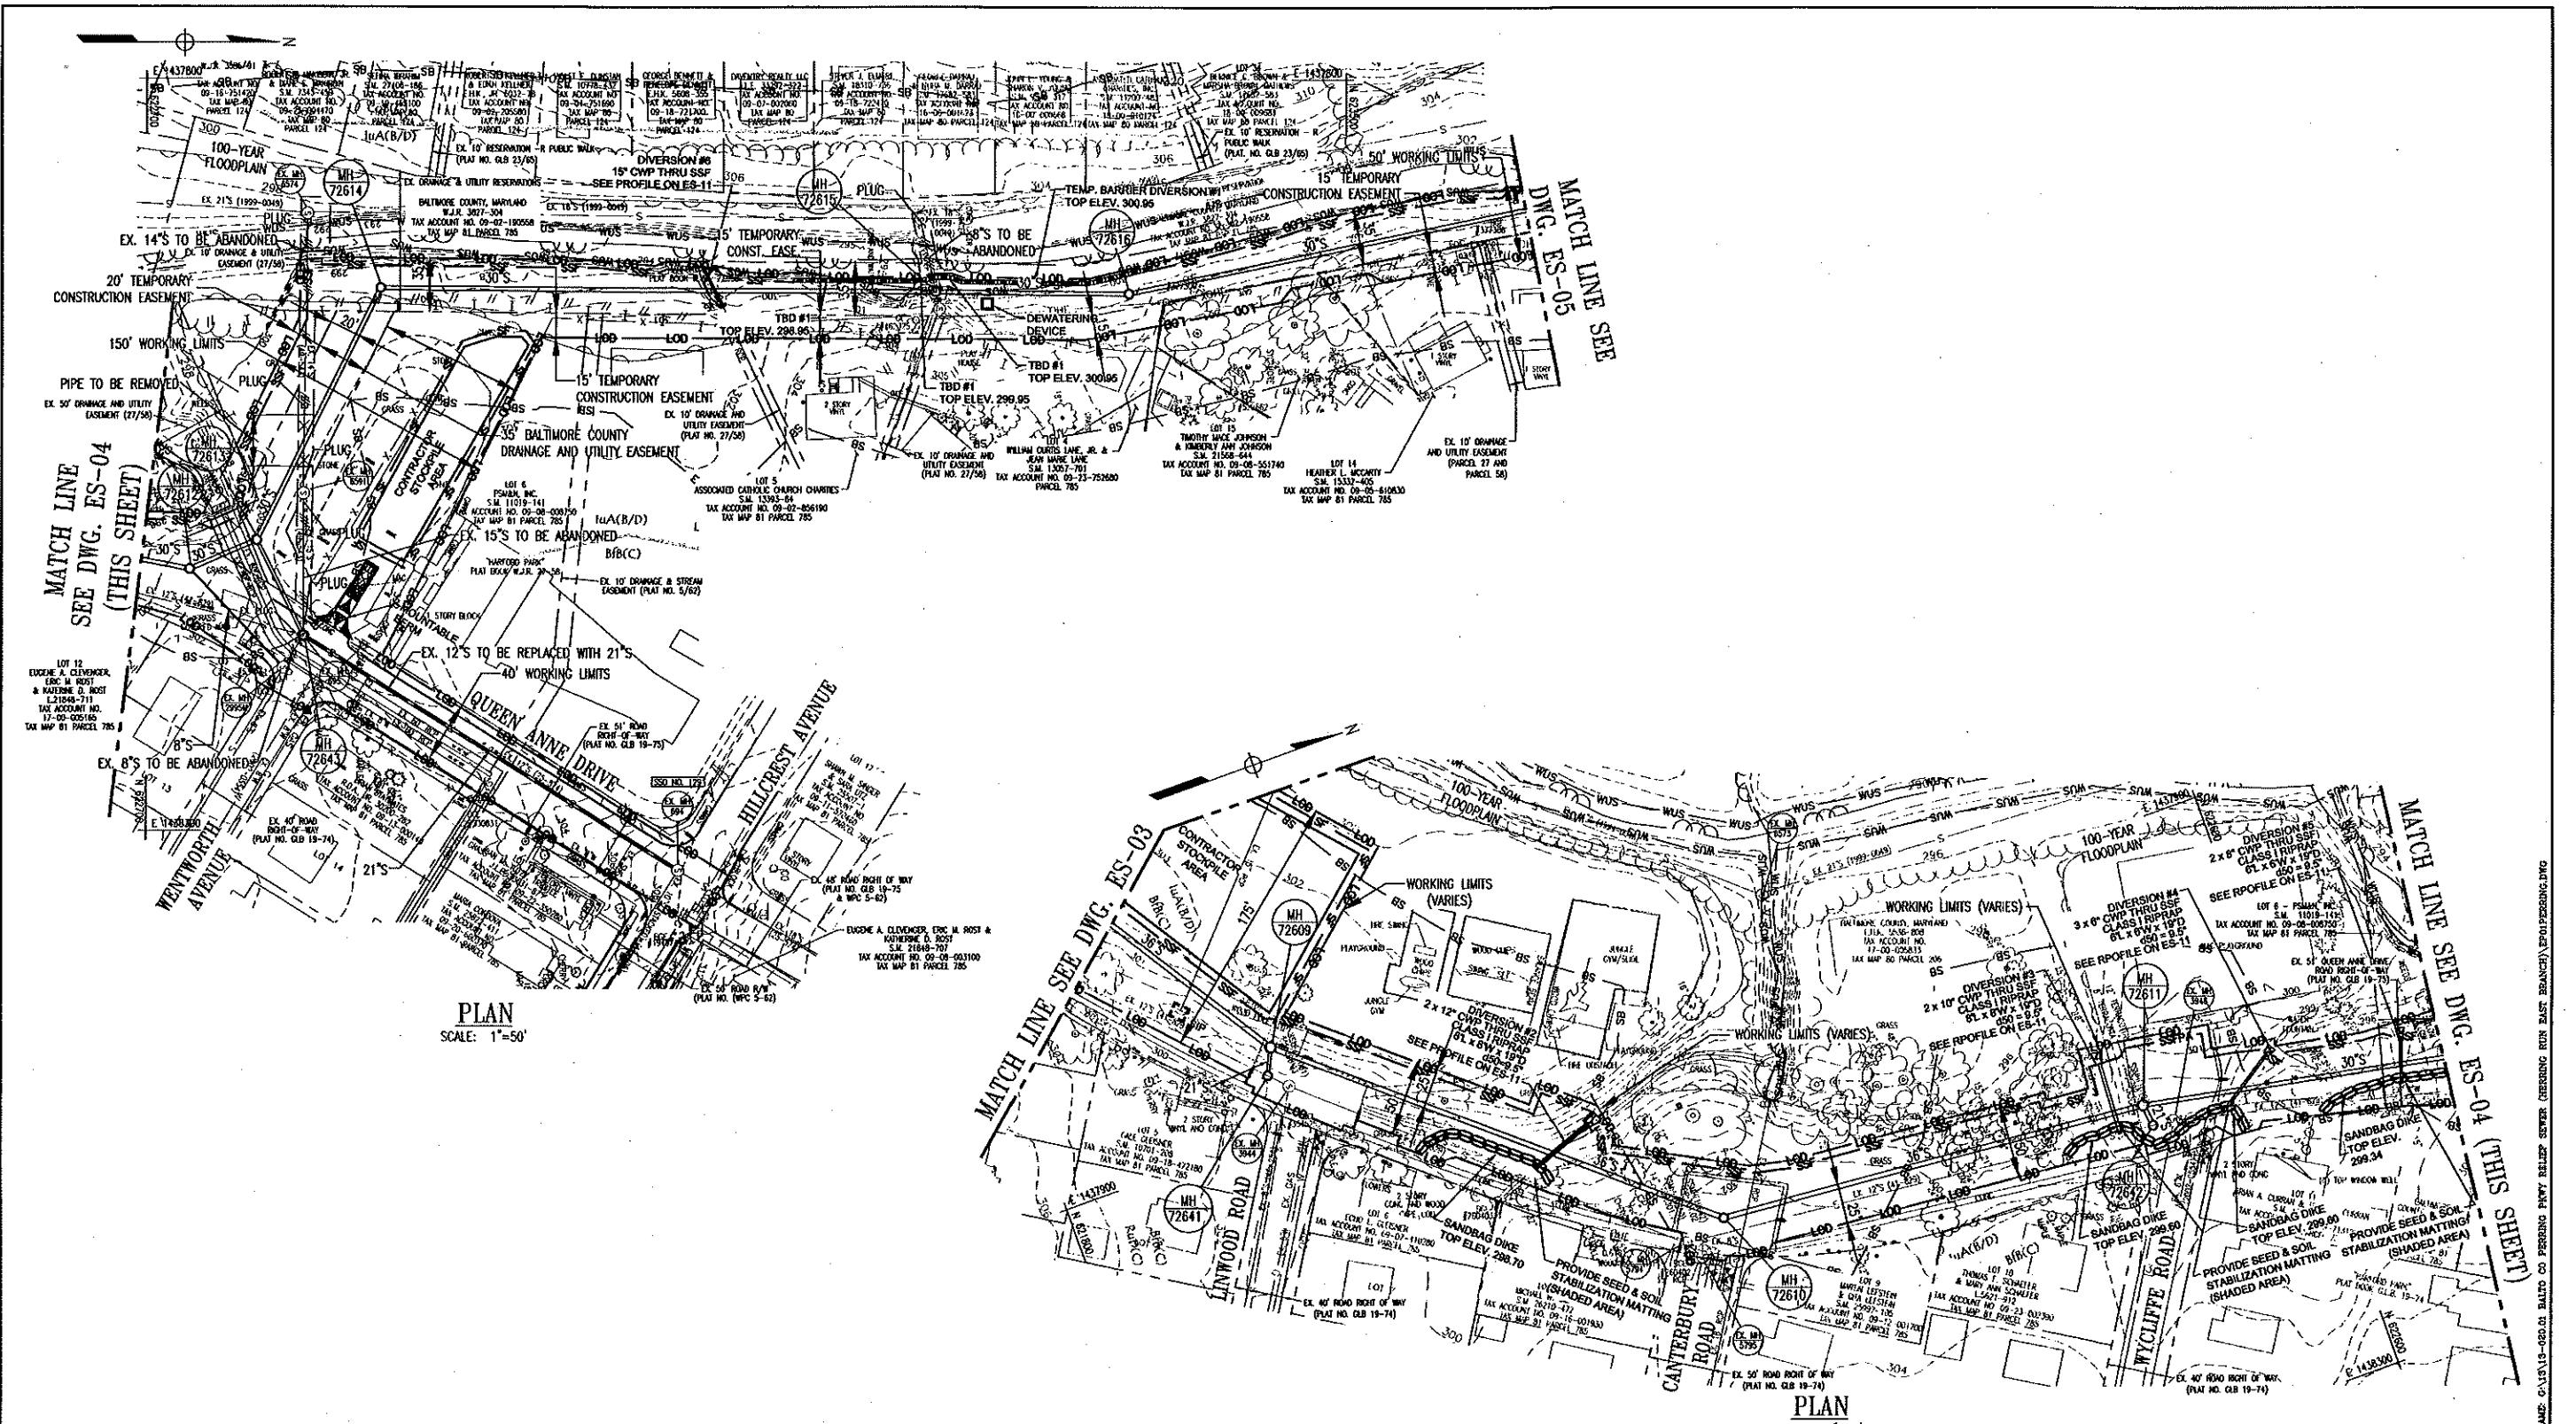

APPROVED FOR SEDIMENT CONTROL
 Baltimore County Soil Conservation District
Jeffrey P. White 6-23-15
 Date

 Design & Drawing based on
 Maryland Coordinate System
 Horizontal - NAD83 (NSRS2007)
 Vertical - NAVD83



EAST BRANCH
 HERRING RUN
 SSO #41 & #129
 CONSENT DECREE

REVISION	BY	DATE	P.W.A. NO.	KEY SHEET POSITION	SHEET	DRAWING SCALE	DEPARTMENT OF PUBLIC WORKS
						PROF. SCALE: N/A <td>DATE:</td>	DATE:
							APPROVED BY: CHIEF
							DATE:

BALTIMORE COUNTY DEPARTMENT OF PUBLIC WORKS BUREAU OF ENGINEERING & CONSTRUCTION
 EAST BRANCH HERRING RUN RELIEF SEWER
 GRADING AND SEDIMENT & EROSION CONTROL PLAN
 SUBDIVISION: PARKVILLE BALTIMORE COUNTY ELECTION DIST. NO. 9C5

SHEET DESIGNATION	CONTRACT NUMBER
ES-04	14117-SX0
	JOB ORDER NUMBER
	201-0077-7103
	SHEET 33 OF 76
	DRAWING NUMBER
	2014-1574
	FILE NO.:



PROFESSIONAL CERTIFICATION
 I HEREBY CERTIFY THAT THESE DOCUMENTS WERE PREPARED OR APPROVED BY ME AND THAT I AM A DULY LICENSED PROFESSIONAL ENGINEER UNDER THE LAWS OF THE STATE OF MARYLAND.
 LICENSE NO. 86658 EXPIRATION DATE 06/30/2022
 ENGINEER: KEVIN WELLS
 PHOENIX ENGINEERING, INC.
 8132 OLD YORK ROAD
 PARKTON, MD 21129
 AS-BUILT PER RECORD PRINT
 DATE: APRIL 9, 2016



DWG. FILENAME: C:\SUS15-00-01 BALCO CO PREPARED PUMP RELIEF SEWER (HERRING RUN BASF BRANCH).PROF.DWG